


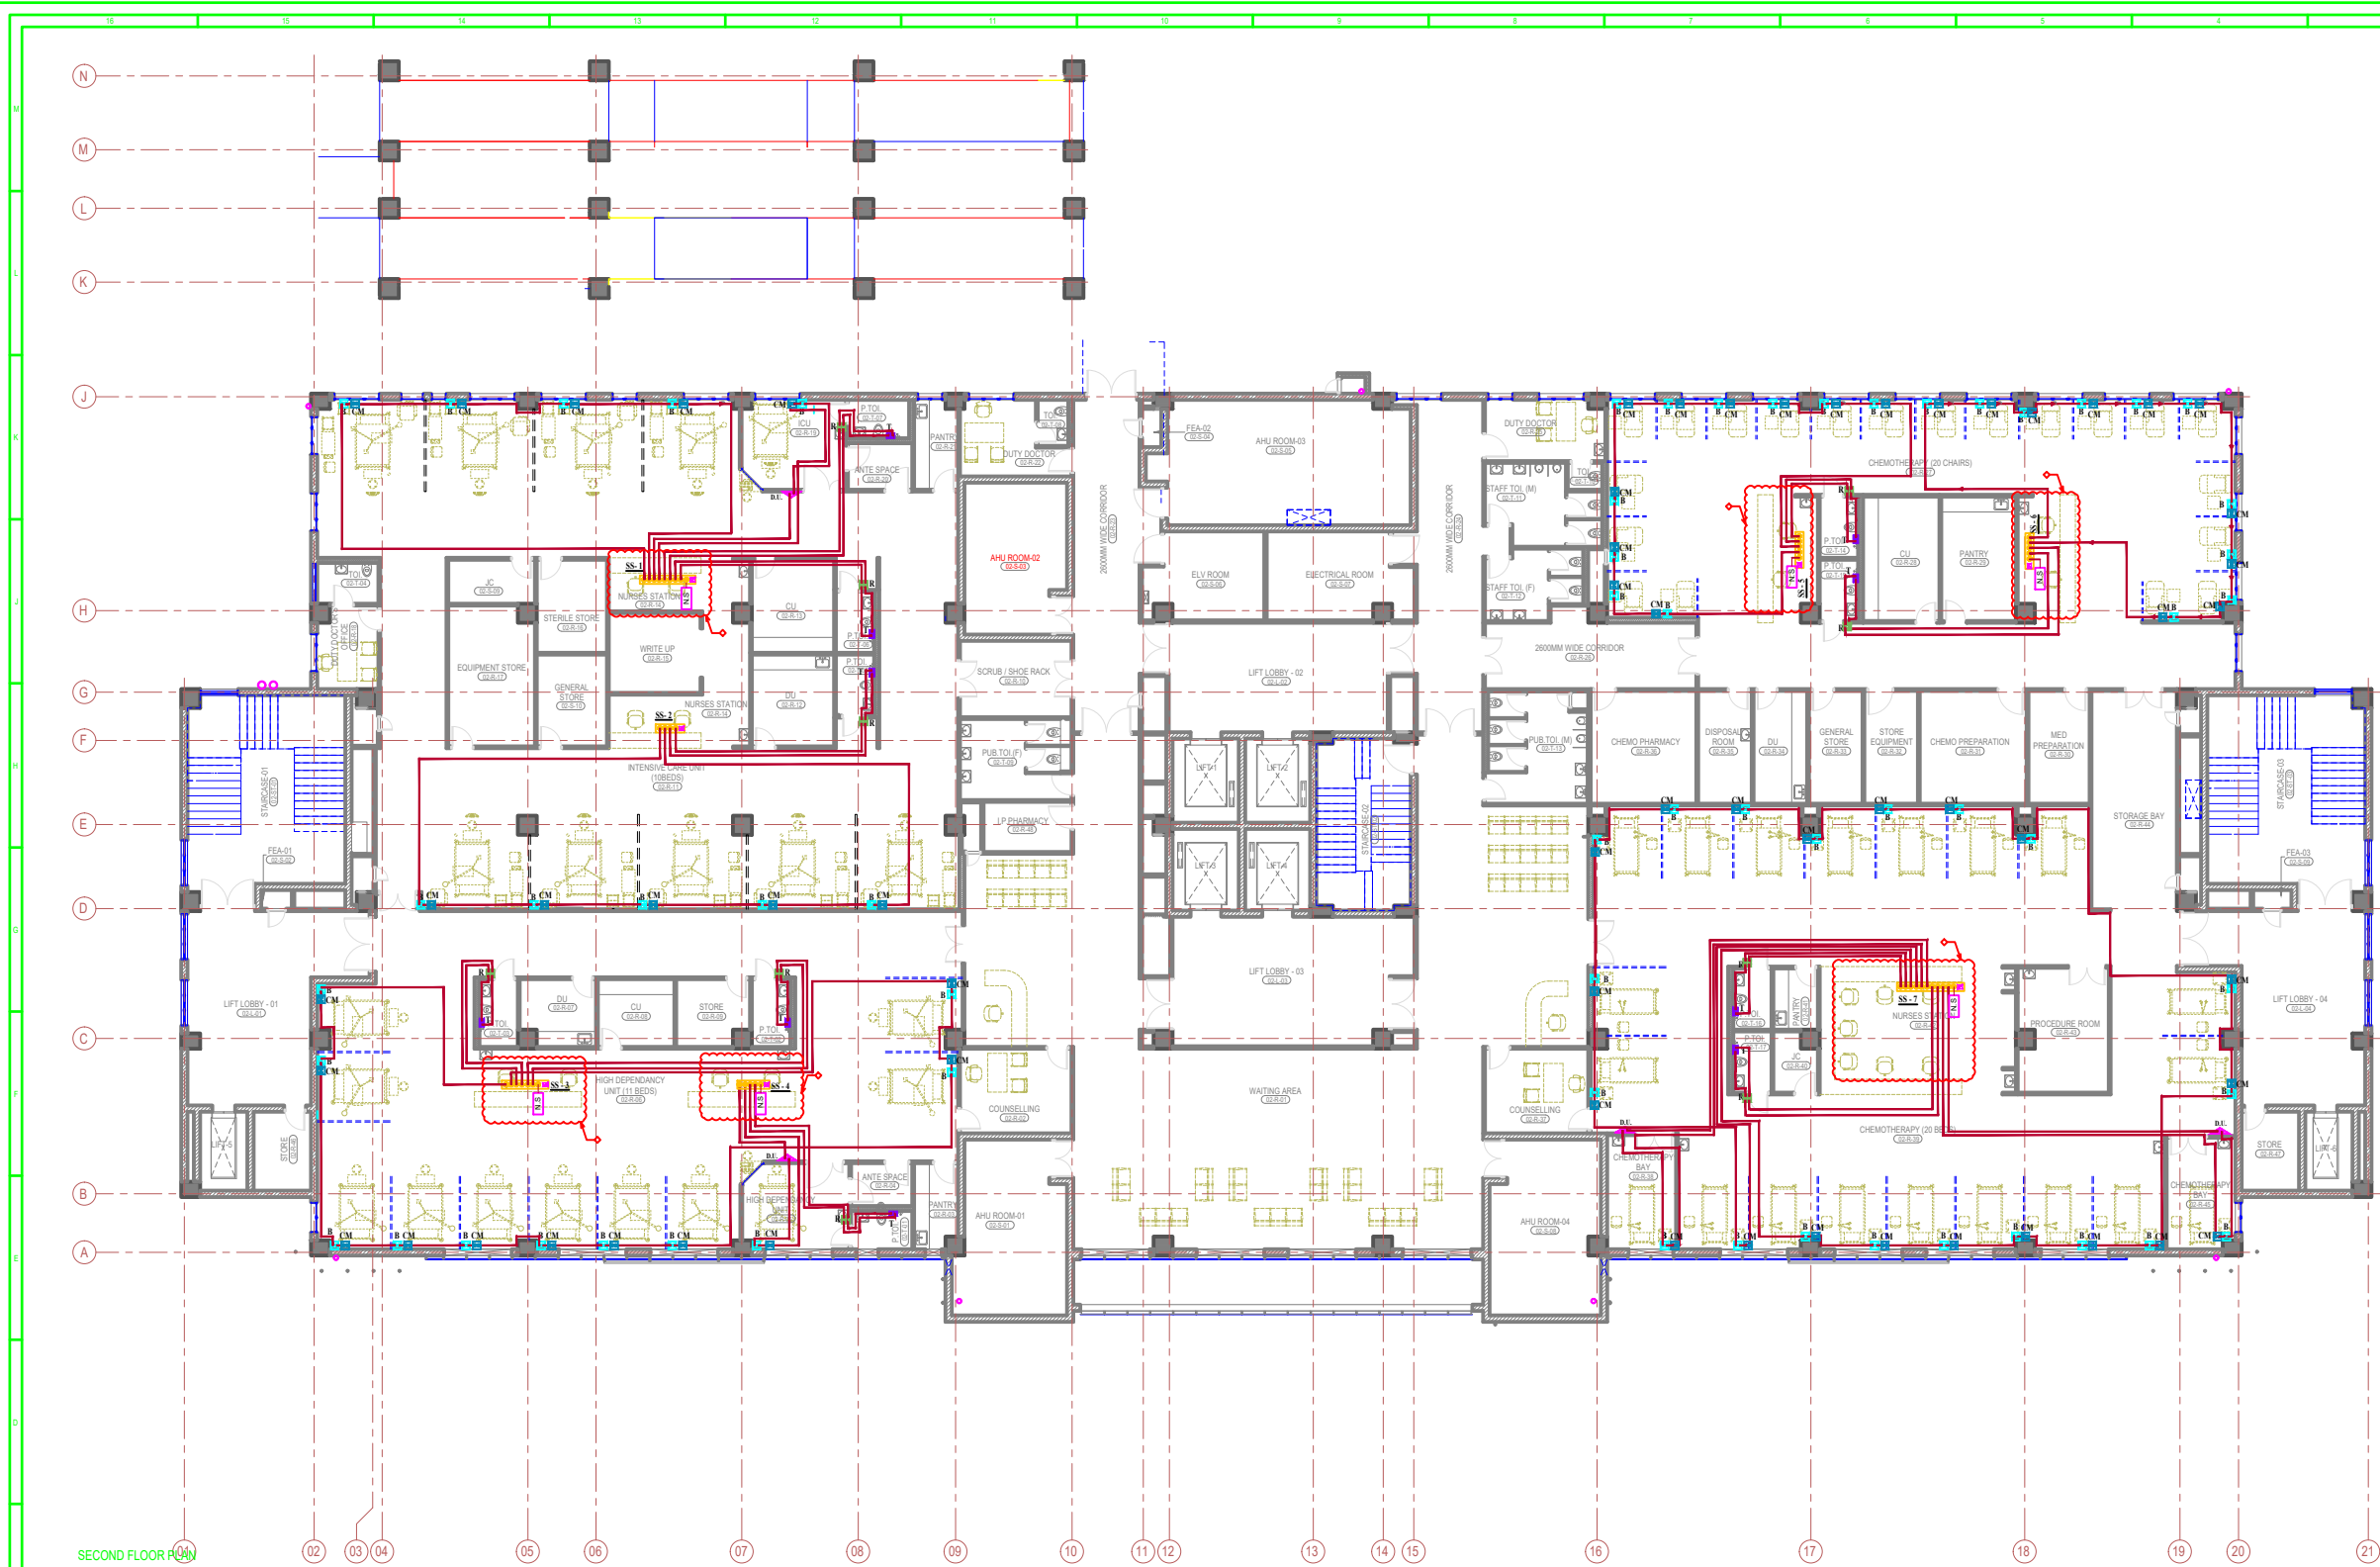

This drawing is the property of L&T Construction, BAF-EDRC and must not be passed on to any person or body not authorised by us to receive it nor be copied or otherwise made use either in full or in part by such person or body without our prior permission in writing.

NURSE CALL POINT LEGEND

SYMBOL	LEGEND	DESCRIPTION
	SS	SYSTEM SWITCH
	N.S	NURSE STATION
	DU	DOOR INDICATOR
	B	BED SIDE UNIT
	CM	CONNECTION MODULE
	R	EMERGENCY RESET UNIT
	T	TOILET PULL CORD
		CAT 6 CABLE

Notes :

- 1.SHOP drawing to be submitted with the provisions of power point and LAN points .
2. This is only concept DWG ,drawing to be submitted as per the BOQ

IS RELEASED AS GOOD FOR CONSTRUCTION		DATE: 10.10.2019		BY: [Signature]	
REVNO.	DESCRIPTION	DESIGNED	DRAWN	CHECKED	APPROVED
CHECKED BY: [Signature]					
ARCHITECTURE	SI/M	DATE	CHECKED BY: [Signature]	SI/M	DATE
CIVIL & STRUCTURAL	SI/M	DATE	CHECKED BY: [Signature]	SI/M	DATE
ELECTRICAL	SI/M	DATE	CHECKED BY: [Signature]	SI/M	DATE
PLUMBING	SI/M	DATE	CHECKED BY: [Signature]	SI/M	DATE
CLV SYSTEM	SI/M	DATE	CHECKED BY: [Signature]	SI/M	DATE
CLIENT: ASSAM CANCER CARE FOUNDATION					
PROJECT: Proposed Cancer Centre At 10 Locations In Assam For Assam Cancer Care Foundation & M/s. T&E Trusts					
PROJECT CONSULTANT: L&T Construction - Buildings & Factories					
CONCEPT: Engineering Design and Research Center (EDRC)					
ARCHITECT: L&T Construction - Buildings & Factories					
SUPPLIER / CONTRACTOR: Larsen & Toubro Limited, Construction, Buildings & Factories					
JOB No: Q10035					
TITLE: DIPHU-NURSE CALL LAYOUT					
SECOND FLOOR PLAN					
DRAWING No: TENDER /ACCF/NCS/DIPHU-2					
RELEASED FOR: ☒ PRELIMINARY ☐ TENDER ☐ INFORMATION ☐ APPROVAL ☐ CONSTRUCTION					