


GROUND FLOOR PLAN
SCALE : 1 : 100




KEY PLAN
SCALE: (NTS)

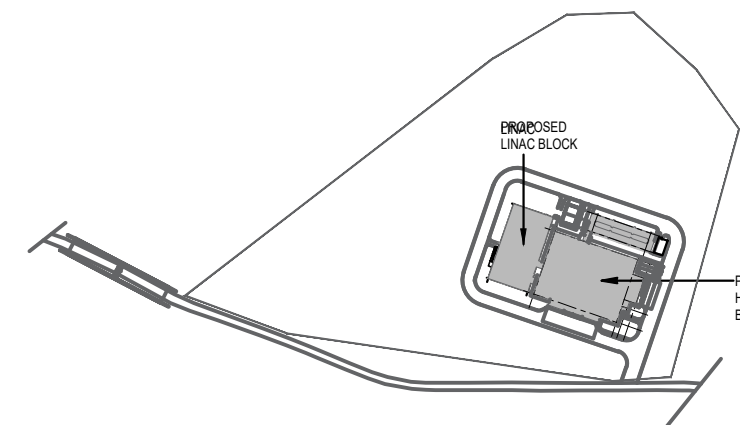


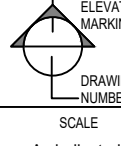
 
GENERAL NOTES:

01. ALL DIMENSIONS ARE IN MILLIMETERS & LEVELS IN METERS.
02. +0.000 FFL REFERS TO +9.30 LEVEL AT SITE.
03. THIS DRAWING SHOULD BE READ IN CONJUNCTION WITH THE ALL FLOOR PLANS, ELEVATIONS & SECTIONS 019035-A-HP-14-WD-0001 TO 0015.

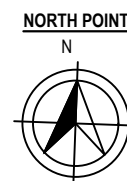This drawing is the property of L&T Construction, B&F-EDRC and must not be passed on to any person or body not authorised by us to receive it nor be copied or otherwise made use either in full or in part by such person or body without our prior permission in writing.



NORTH POINT:
N

A		SUBMITTED FOR APPROVAL				ARUN		10.11.2019	SSV	10.11.2019	TI	11.11.2019	JA	14.11.2019									
REV NO.		DESCRIPTION				DESIGNED		DRAWN		CHECKED		APPROVED											
CHECKED BY		SIGN		DATE		CHECKED BY		SIGN		DATE		CHECKED BY		SIGN		DATE							
ARCHITECTURE						HVAC						GIS											
CIVIL & STRUCTURAL						FPS						GEOTECH											
ELECTRICAL						PIPING						VHT											
ELV SYSTEM						PHE																	
CLIENT :		 ASSAM CANCER CARE FOUNDATION ASSAM CANCER CARE FOUNDATION KOKRAJHAR CANCER CENTRE (A Government of Assam and Tata Trusts Initiative)				 L&T Construction Buildings & Factories																	
ASSAM CANCER CARE FOUNDATION																							
PROJECT : Proposed Cancer Centre At 18 Locations In Assam For Assam Cancer Care Foundation & M/s. Tata Trusts																							
KOKRAJHAR CANCER CENTRE (A Government of Assam and Tata Trusts Initiative)																							
CONSULTANT: Engineering Design and Research Center (EDRC), L&T Construction - Buildings & Factories.																							
CONCEPT ARCHITECT: Engineering Design and Research Center (EDRC), L&T Construction - Buildings & Factories.																							
SUPPLIER / CONTRACTOR : Larsen & Toubro Limited, Construction, Buildings & Factories																							
JOB No : 019035				TITLE:				HOSPITAL BLOCK															
				GROUND FLOOR PLAN								SCALE As indicated											
NAME		SIGN		DATE																			
DESIGN		ARUN		10.11.2019																			
DRAWN		SSV		10.11.2019																			
CHECKD		TI		11.11.2019																			
APPROD		JA		14.11.2019																			
DRAWING No: 019035 - A - HP - 14 - WD - 0009				SHEET:								PROJECTION SCALE		SIZE A4		REV A							
RELEASED FOR				<input type="checkbox"/> PRELIMINARY				<input type="checkbox"/> TENDER				<input type="checkbox"/> INFORMATION				<input checked="" type="checkbox"/> APPROVAL				<input type="checkbox"/> CONSTRUCTION			